



Appendix 2.12-4

Exterior Lighting Plan


LIGHTING DESIGN

Exterior Lighting

LEGEND

Luminaire Schedule					
Symbol	Type	Kelvin	Wattage	Lumens	Mounting
•	TXA	3000K	600 ea	27024	40' POLE
—	TXB	3000K	108 ea	10690	24' POLE
•	TXB-1	3000K	54 ea	5346	24' POLE
•	TXC	3000K	12 ea	423	30" BOLLARD
•	TXD	3000K	7.7 ea	189	INGROUND TREE UPLIGHT
•	TXF	3000K	9 ea	726	RECESSED CEILING ACCENTLIGHT
—	TXG	3000K	5.2 ea	245	SURFACE MOUNTED TAPE LIGHT
•	TXH	3000K	7 ea	467	STAKE MOUNTED TREE UPLIGHT
•	TXK	3000K	44 ea	7316	30' POLE
•	TXX	3000K	7.5 ea	531	SURFACE MOUNTED FLOOD LIGHT

Luminaire Schedule					
Symbol	Type	Kelvin	Wattage	Lumens	Mounting
•	TXK-1	3000K	88 ea	14632	40' POLE
•	TXM	3000K	6 ea	330	RECESSED CEILING DOWNLIGHT
—	TXN, TXN-1, TXN-2	3000K	3.1 ln.ft	100	SURFACE MOUNTED TAPE LIGHT
•	TXP	3000K	5 ea	48	INGROUND UPLIGHT
•	TXQ	2700K	6 ln.ft	332	SURFACE MOUNTED LINEAR
•	TXR	3000K	11 ea	950	RECESSED CEILING ACCENTLIGHT
•	TXS	3000K	16 ea	2160	SURFACE MOUNTED ACCENTLIGHT
—	TXU	3000K	12 ln.ft	729	LINEAR GRAZER
•	EPR	3000K	85 ea	10828	EXISTING POLES TO REMAIN

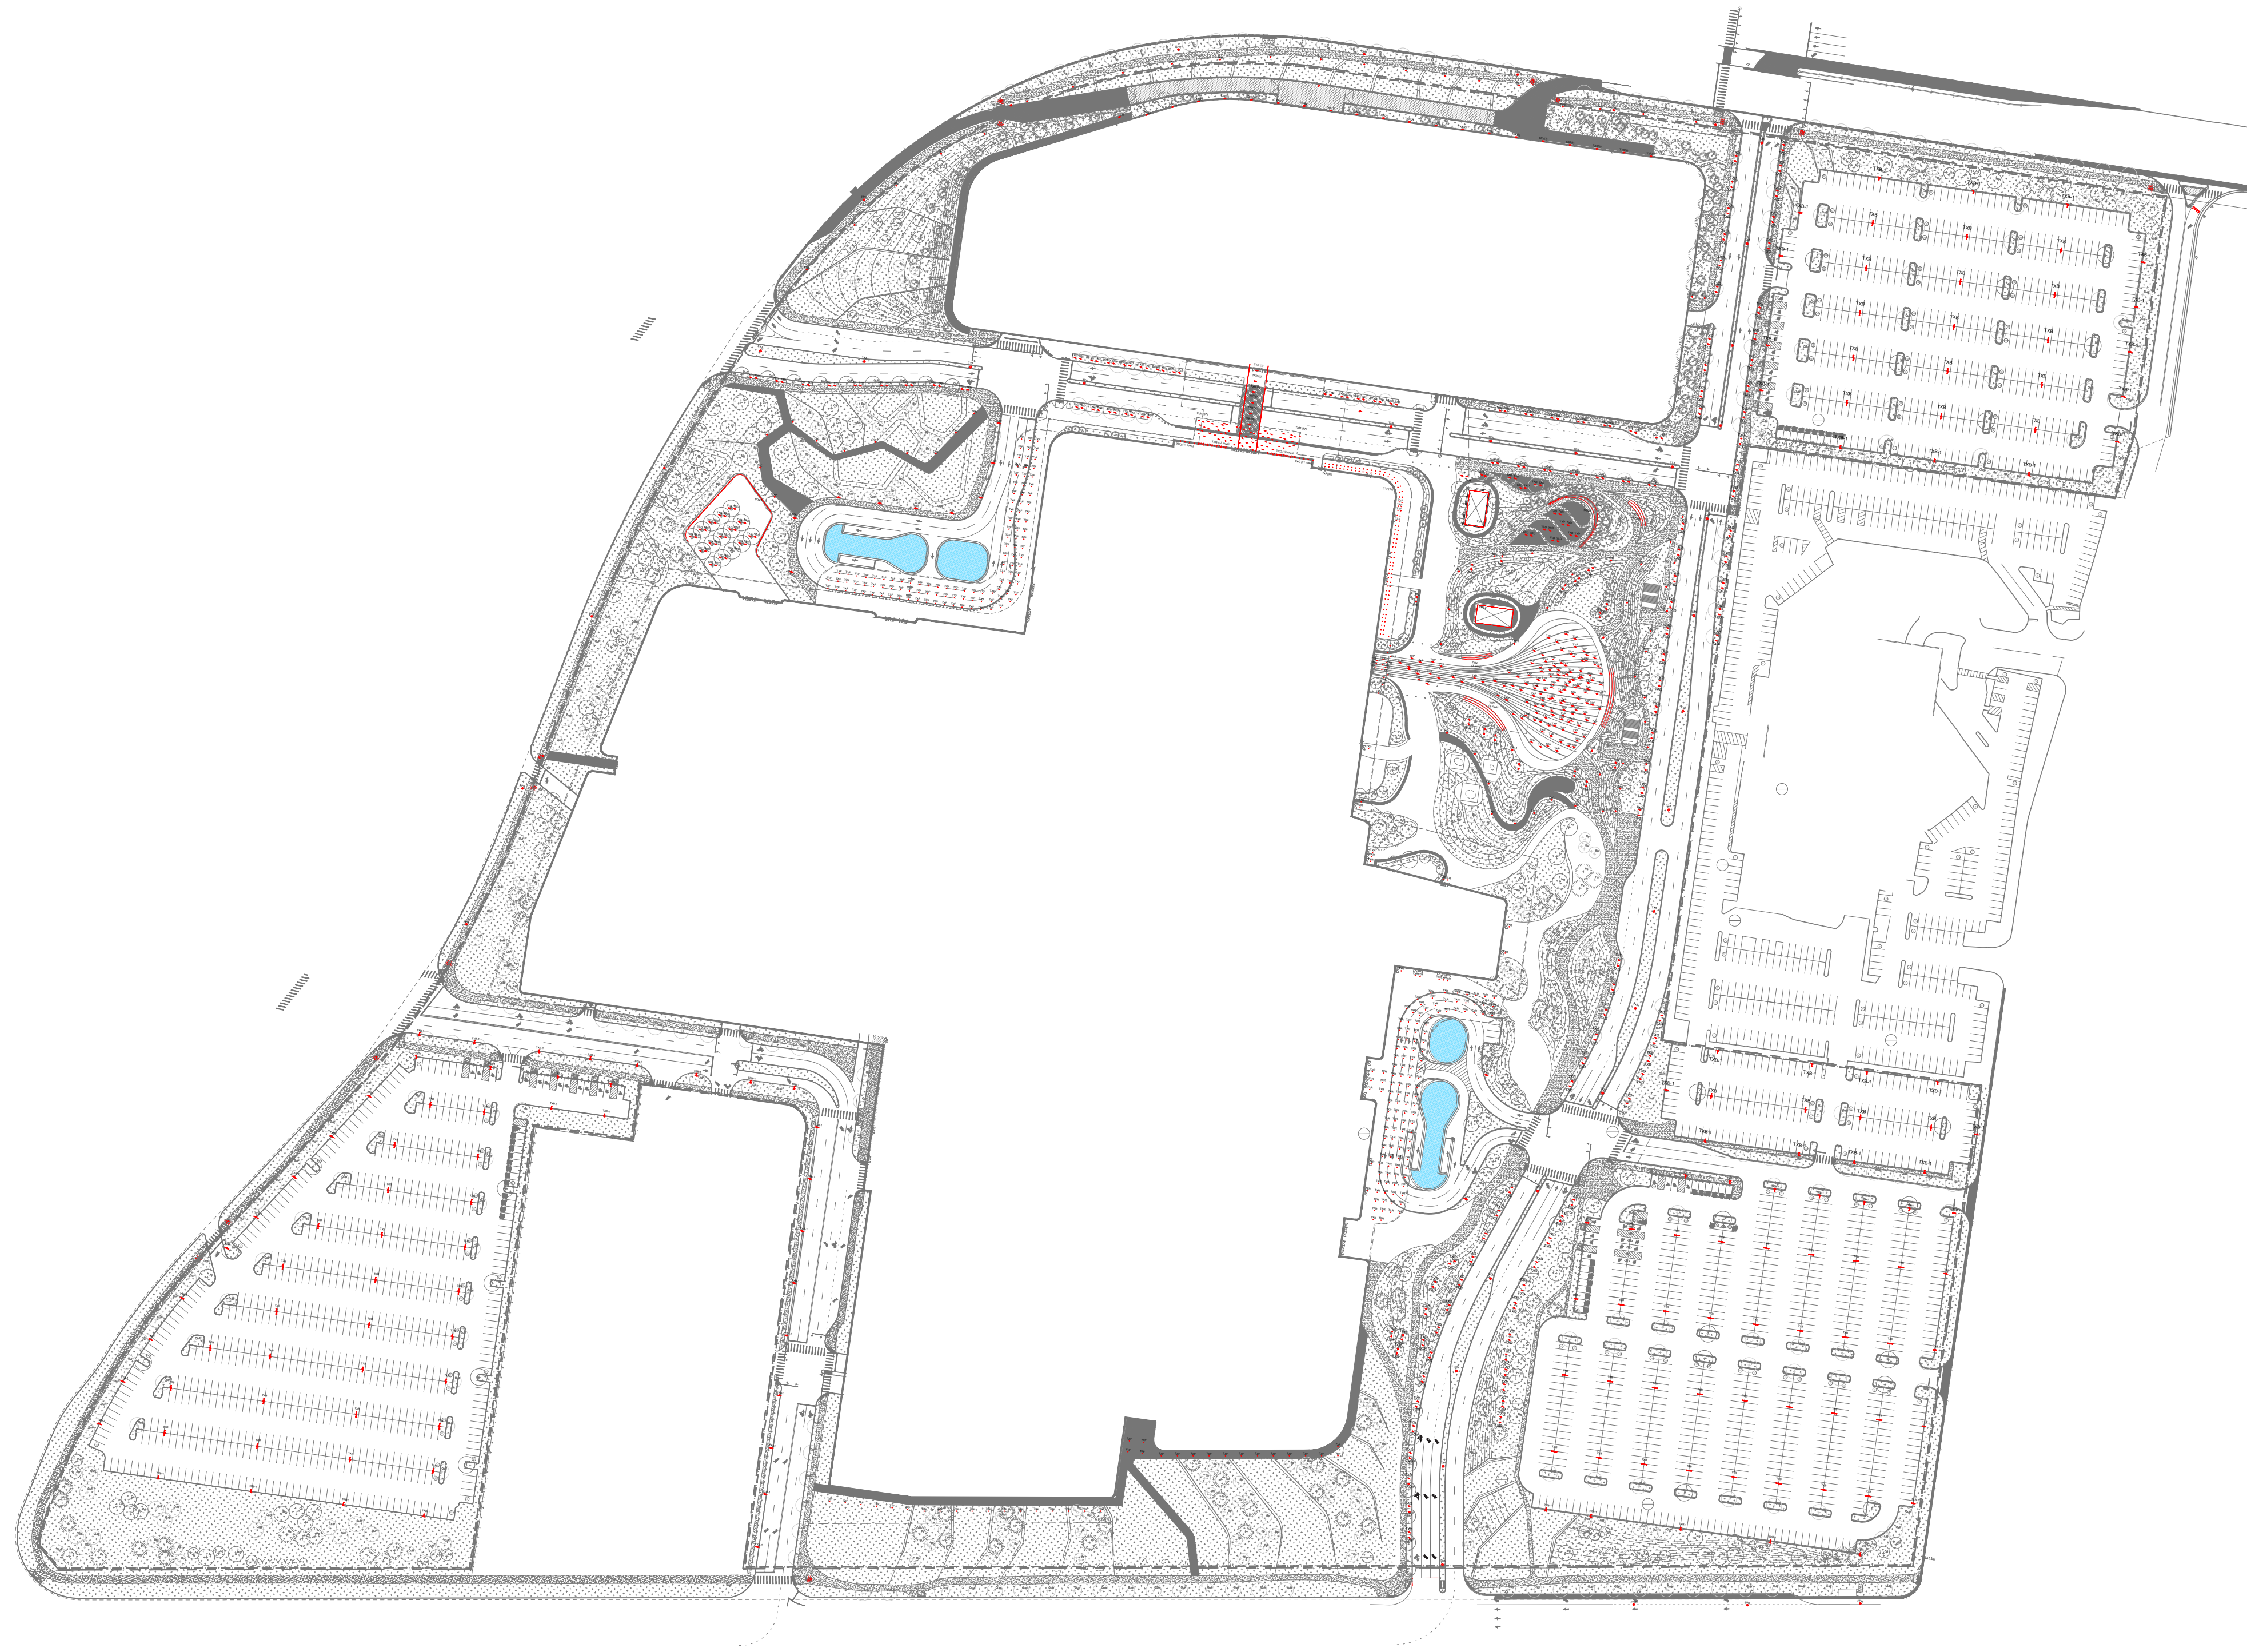


SCALE: 1" = 100'




LIGHTING DESIGN



Exterior Lighting

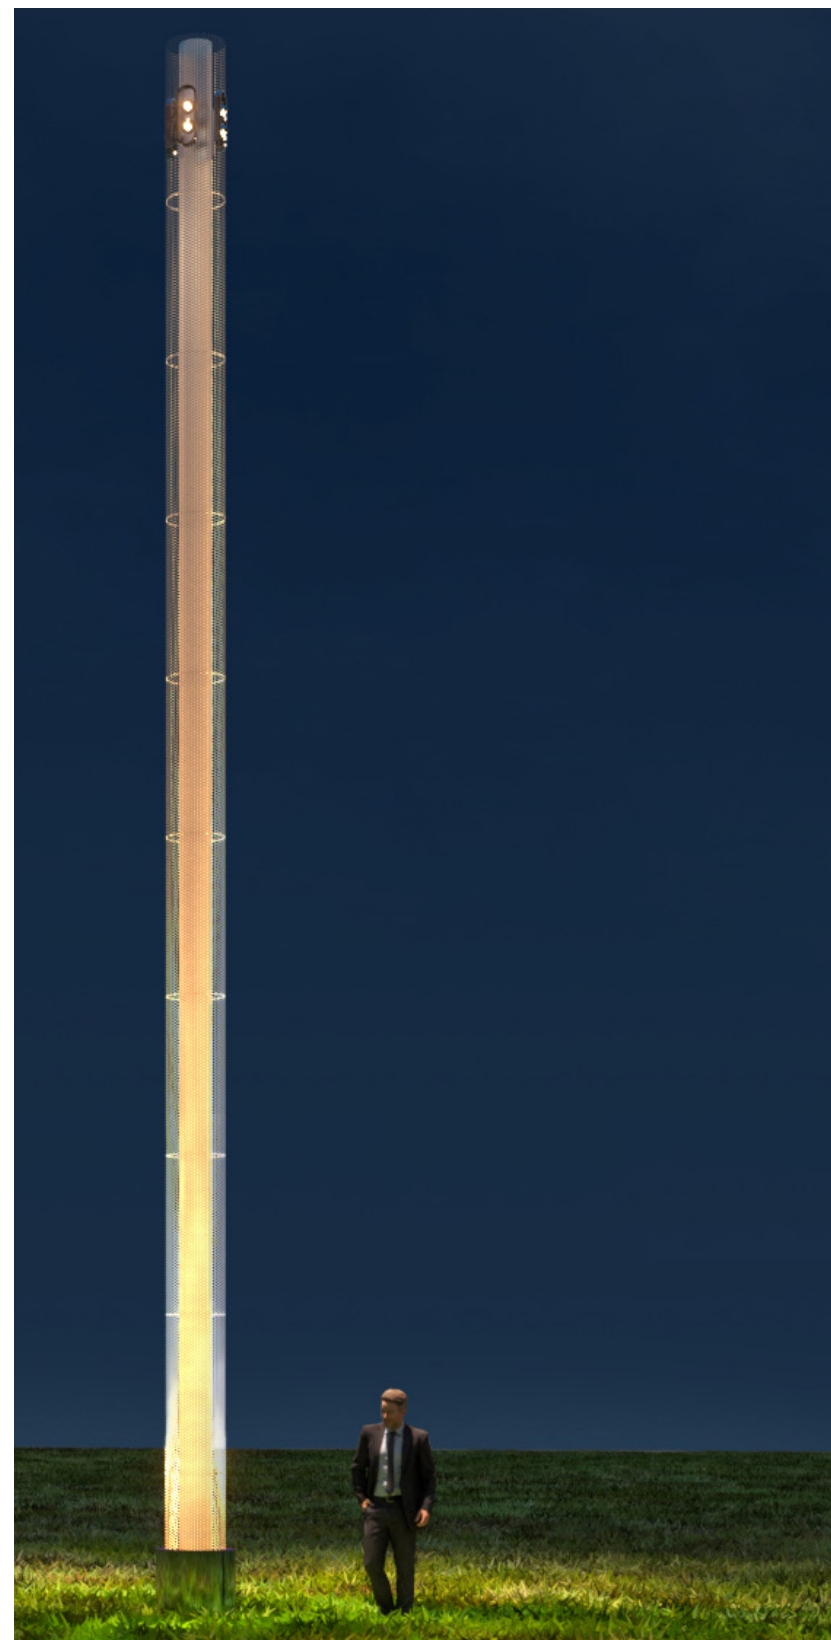

TYPE TXA
CUSTOM SIGNATURE POLE
40' HIGH

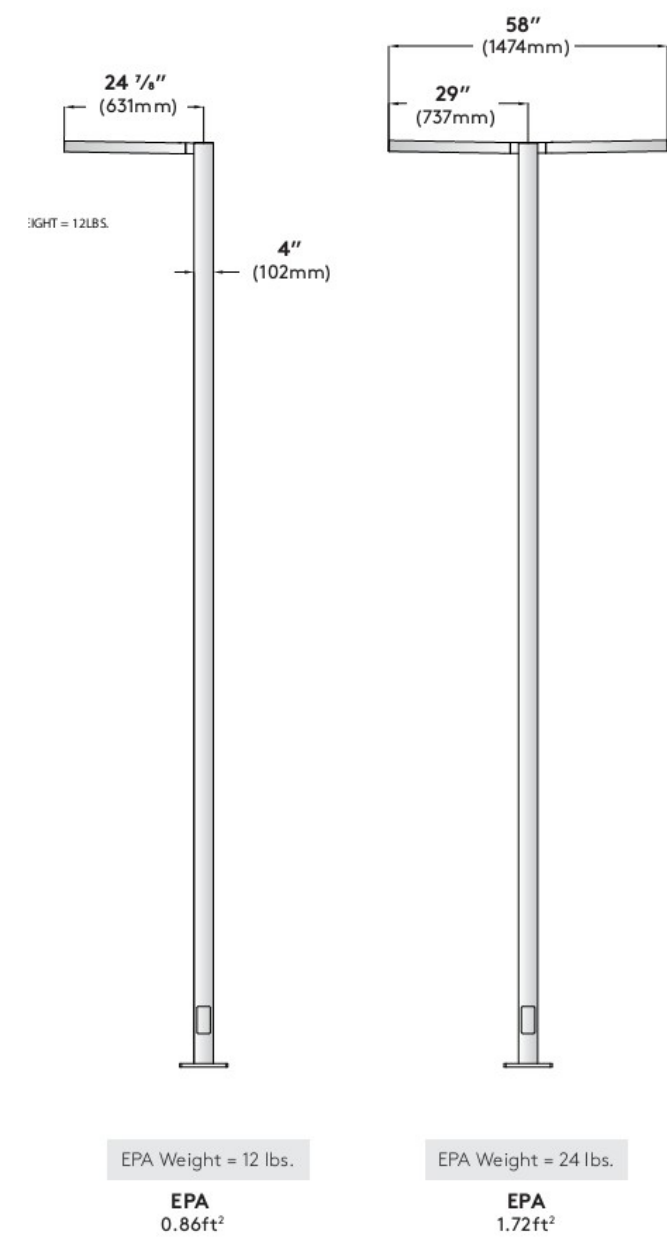

TYPE TXB, TXB-1
PARKING POLE 24'
HIGH

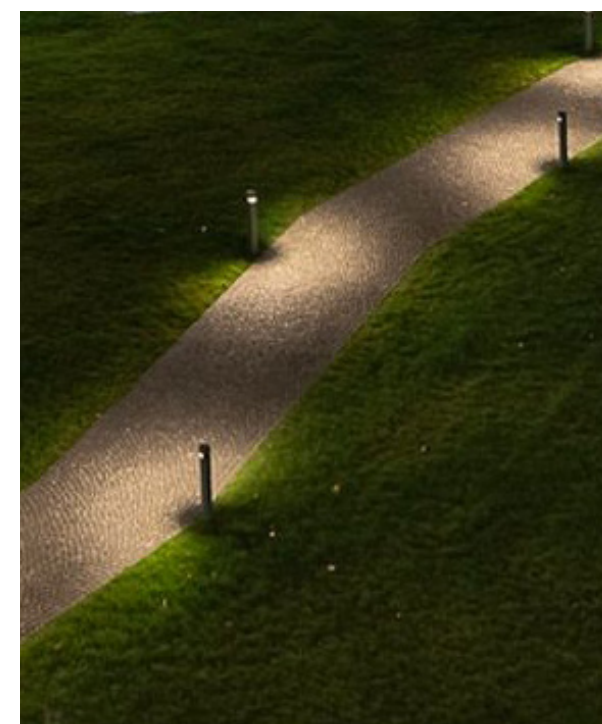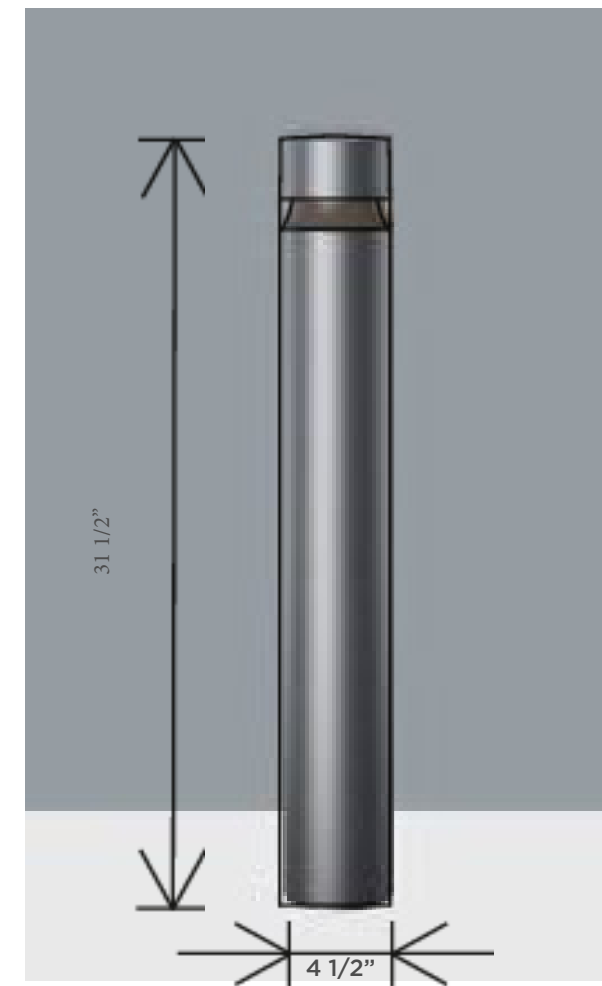

TYPE TXC
BOLLARD 31.5" HIGH




TXP - INGROUND
LENSED UPLIGHT



TYPE TXD
LED FIXTURE WITH INTEGRAL
DRIVER



TYPE TXH
LED FIXTURE WITH INTEGRAL
DRIVER

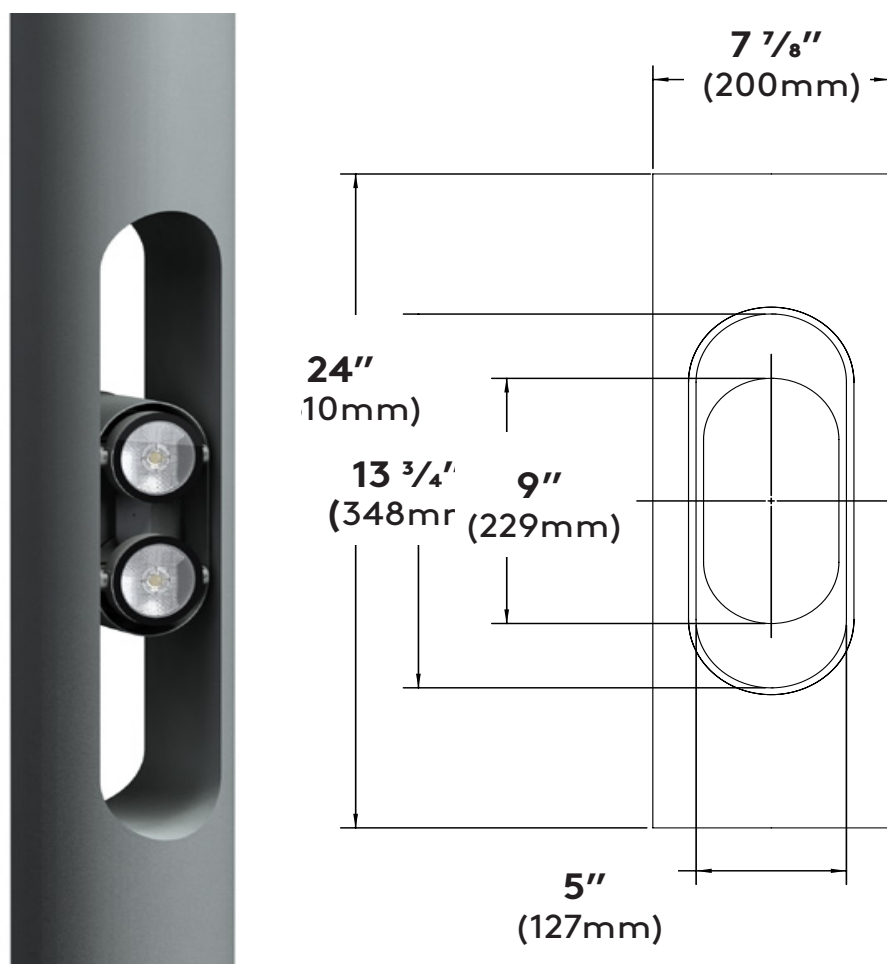

TYPE TXK
30' POLE & 45' POLE AT EAST
PLAZA WITH ACCENT LIGHTS



TYPE TXD
INGROUND ADJUSTABLE UPLIGHT



TYPE TXN
LINEAR TAPE LIGHT AT STEPPED SEATING




TYPE TXF, TXM , TXR
LOW BRIGHTNESS RECESSED
DOWNLIGHTS

LEGEND

Symbol	Type	Kelvin	Wattage	Lumens	Mounting
•	TXA	3000K	600 ea	27024	40' POLE
•	TXB	3000K	108 ea	10690	24' POLE
•	TXB-1	3000K	54 ea	5346	24' POLE
•	TXC	3000K	12 ea	423	30" BOLLARD
•	TXD	3000K	7.7 ea	189	INGROUND TREE UPLIGHT
•	TXE	3000K	9 ea	726	RECESSED CEILING ACCENTLIGHT
•	TXF	3000K	5.2 ea	245	SURFACE MOUNTED TAPE LIGHT
•	TXH	3000K	7 ea	467	STAKE MOUNTED TREE UPLIGHT
•	TXK	3000K	44 ea	7316	30' POLE
•	TXX	3000K	7.5 ea	531	SURFACE MOUNTED FLOOD LIGHT

Symbol	Type	Kelvin	Wattage	Lumens	Mounting
•	TXK-1	3000K	88 ea	14632	40' POLE
•	TXM	3000K	6 ea	330	RECESSED CEILING DOWNLIGHT
•	TXN, TXN-1, TXN-2	3000K	3.1 in.ft	100	SURFACE MOUNTED TAPE LIGHT
•	TXP	3000K	5 ea	48	INGROUND UPLIGHT
•	TXQ	2700K	6 in.ft	332	SURFACE MOUNTED LINEAR
•	TXR	3000K	11 ea	950	RECESSED CEILING ACCENTLIGHT
•	TXS	3000K	16 ea	2160	SURFACE MOUNTED ACCENTLIGHT
•	TXU	3000K	12 in.ft	729	LINEAR GRAZER
•	EPR	3000K	85 ea	10828	EXISTING POLES TO REMAIN

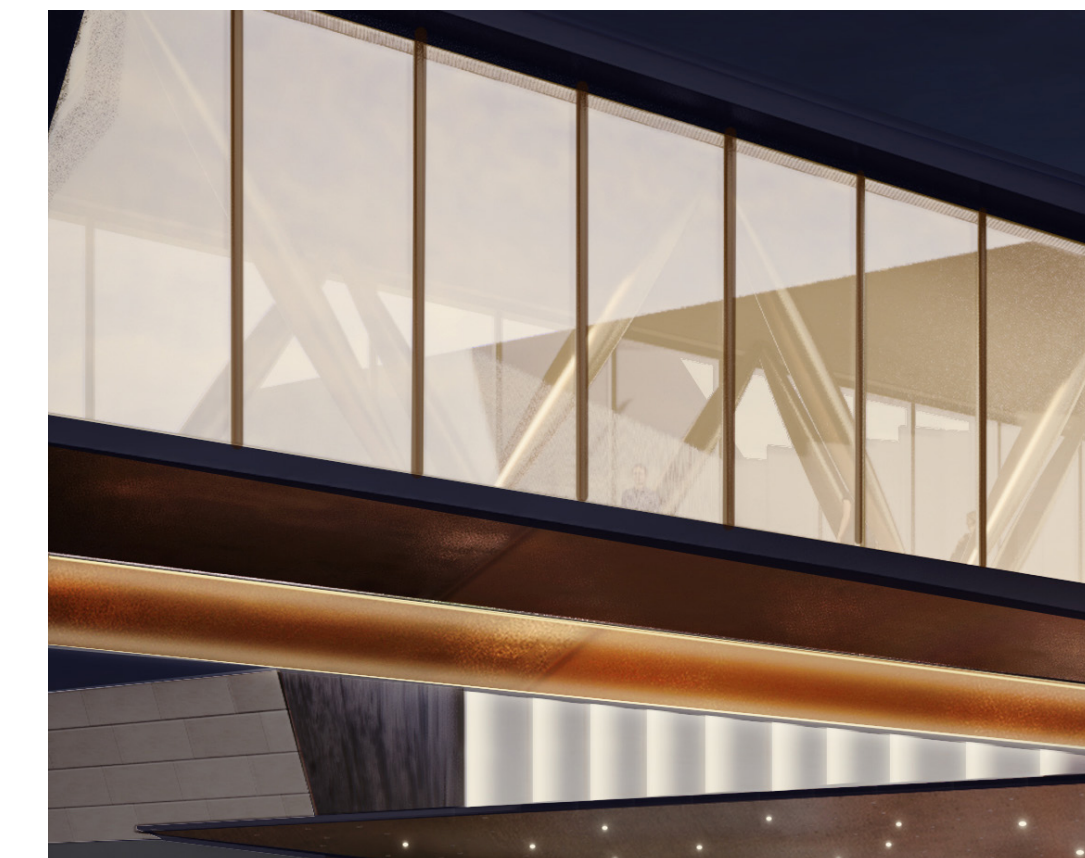

TYPE TXG
LINEAR TAPE LIGHT AT BRIDGE



TYPE TXU - LINEAR GRAZER